

ANY EQUIPMENT SUPPLIED BY OTHERS OR BY OWNER ARE TO BE VERIFIED.


IT WILL BE THE RESPONSIBILITY OF THE OWNER TO SUPPLY UTILITY REQUIREMENTS TO HIS ARCHITECT/ENGINEER/CONTRACTOR



EASTERN
FOOD EQUIPMENT




EASTERN
FOOD EQUIPMENT

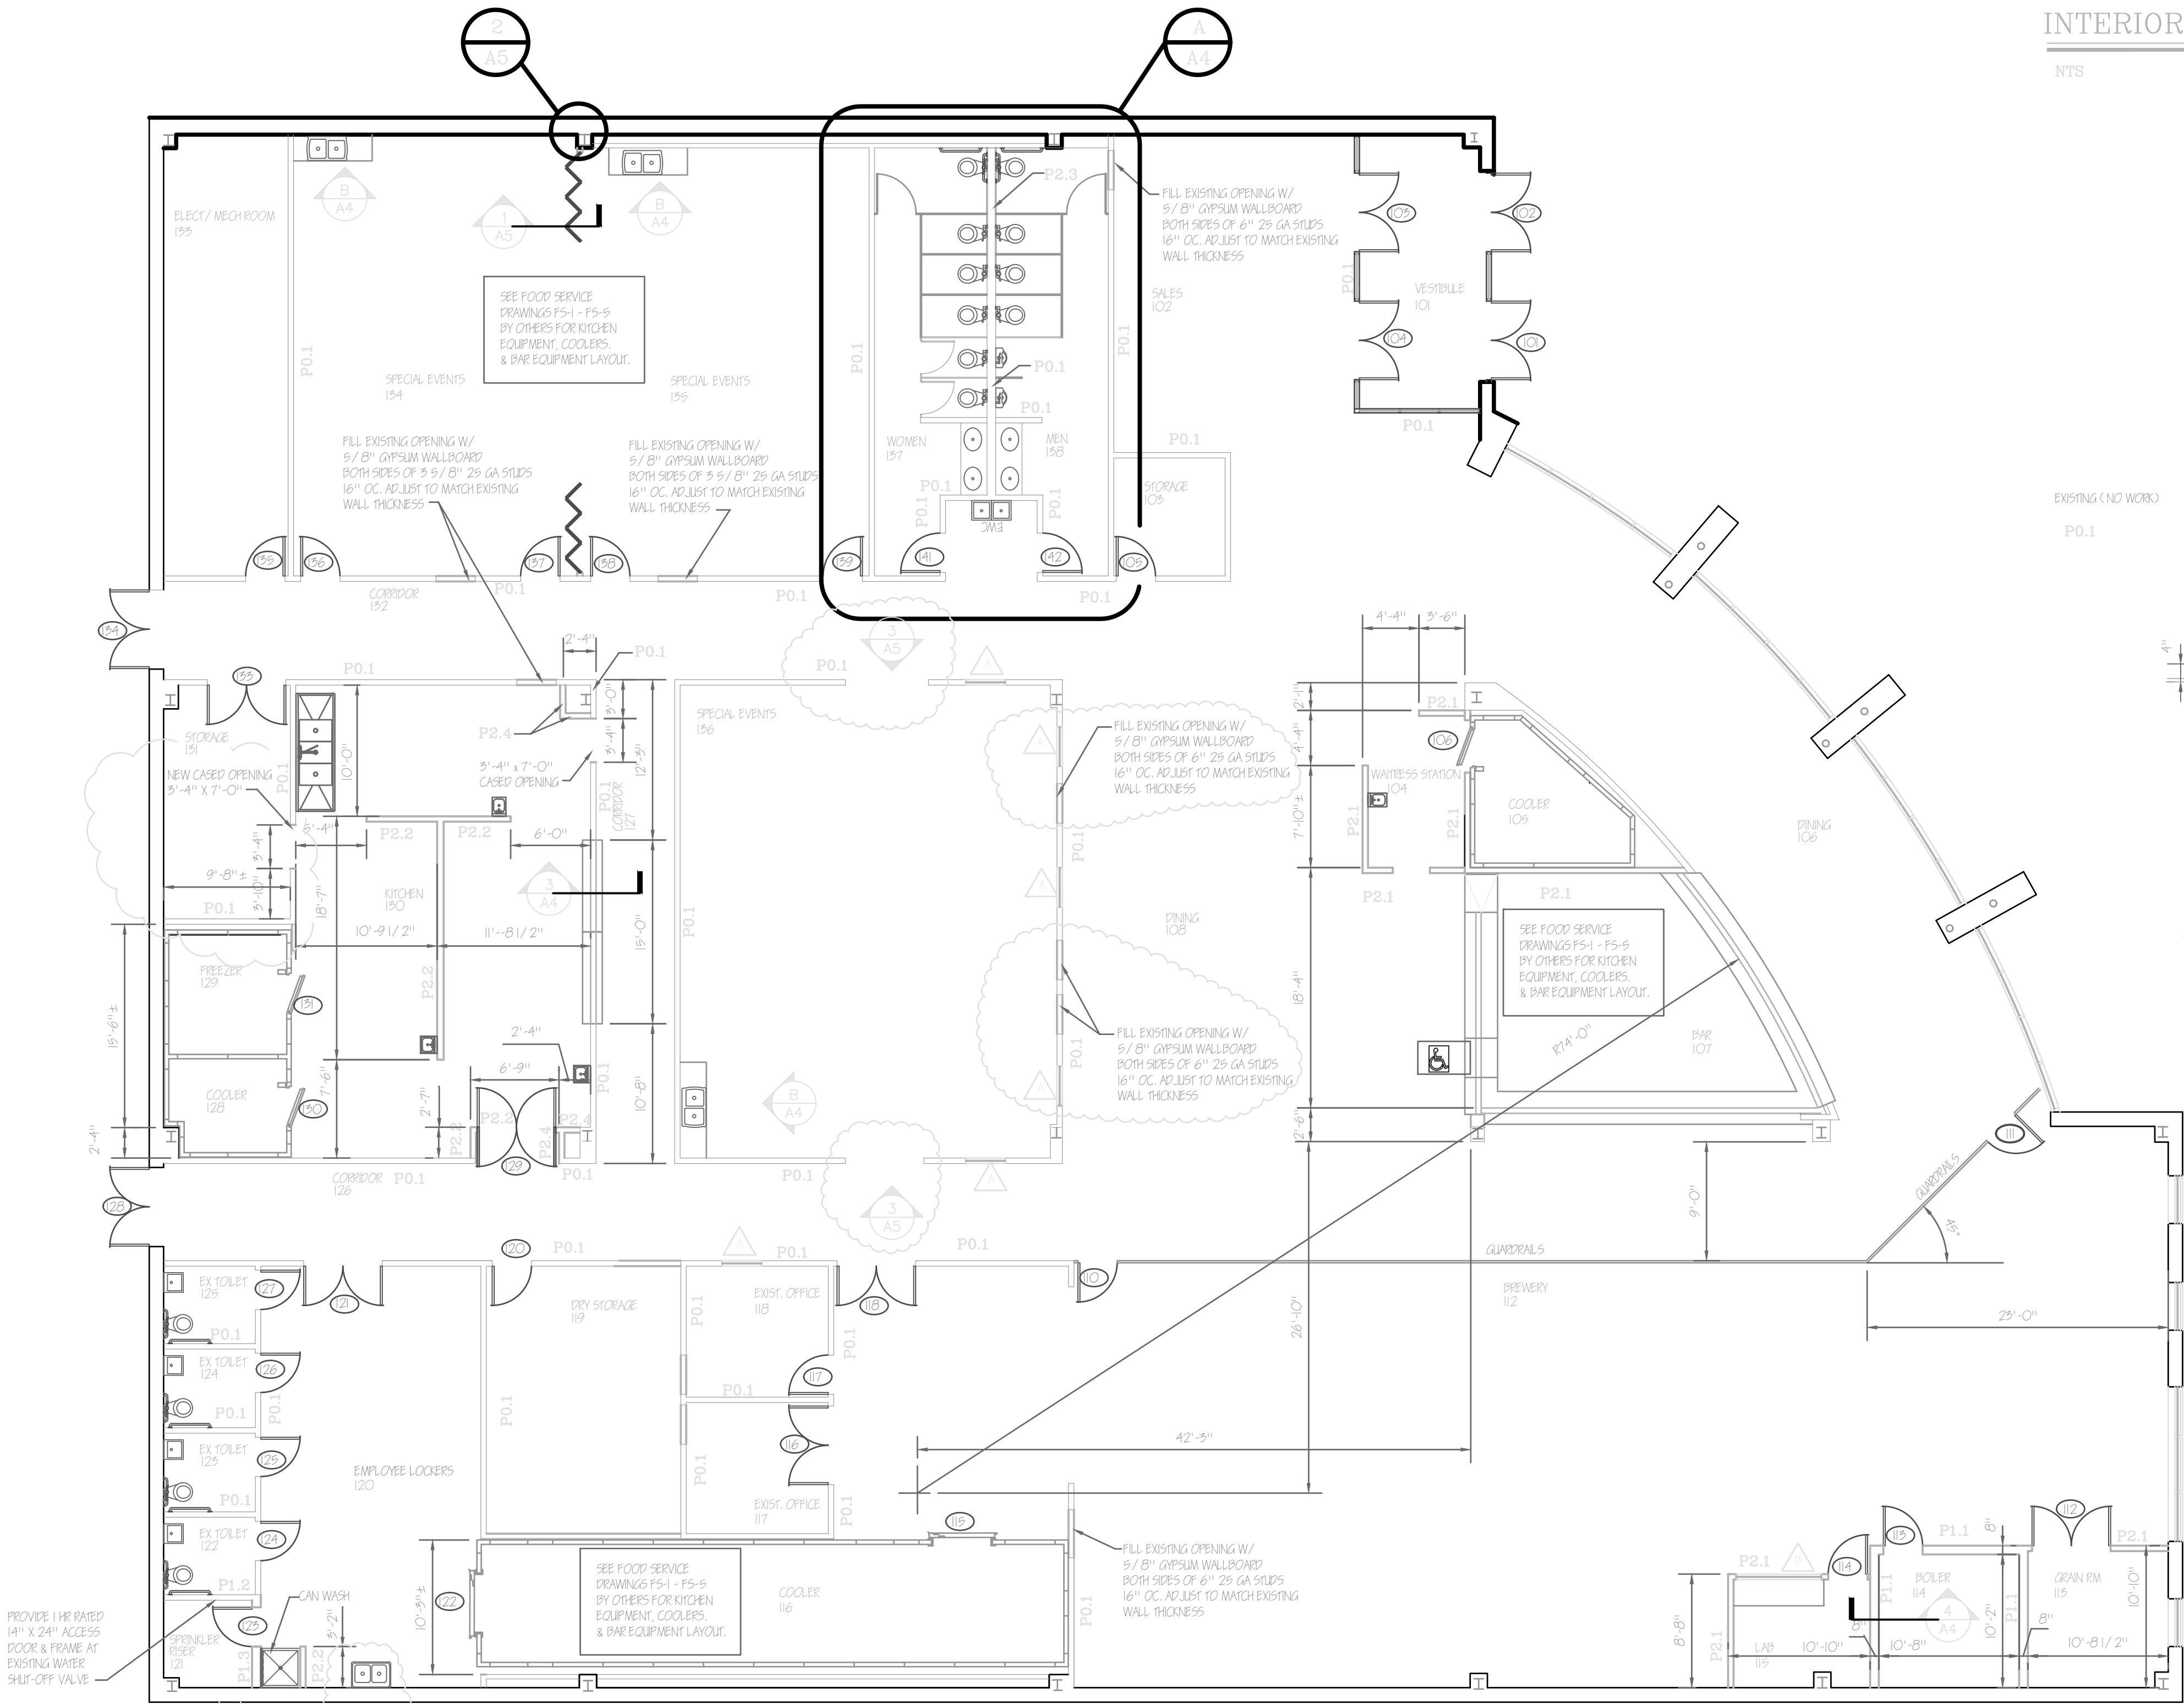


FLOOR PLAN

1/8" = 1'-0" AREA = 15,748 SF

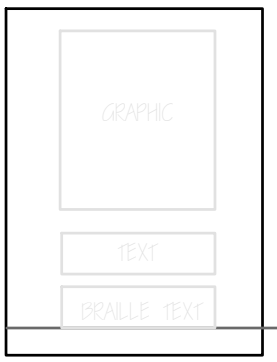

TYPICAL SIGN

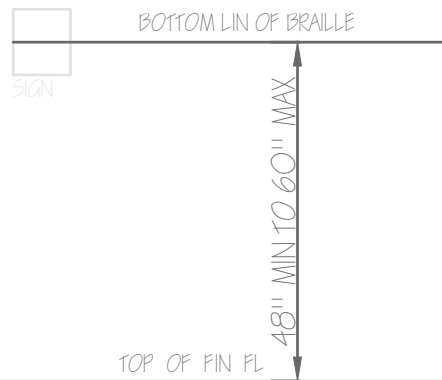


TYPICAL SIGN MOUNTING

FINISH ABBREVIATIONS

- ACT ACOUSTICAL CEILING TILE (2 X 4)
- ACT-1 WASHABLE CEILING TILE (2 X 4)
- CT CERAMIC TILE
- CMU CONCRETE MASONRY UNITS
- EP EPOXY FLOORING
- EX EXISTING
- FRP REINFORCED FIBERGLAS PANELS (SMOOTH)
- GP GYPSUM WALLBOARD
- P PAINT
- POL POLISHED
- ST STRUCTURE (METAL DECKING, BEAMS, & JOISTS)
- V VINYL


INTERIOR PARTITION SCHEDULE

NTS

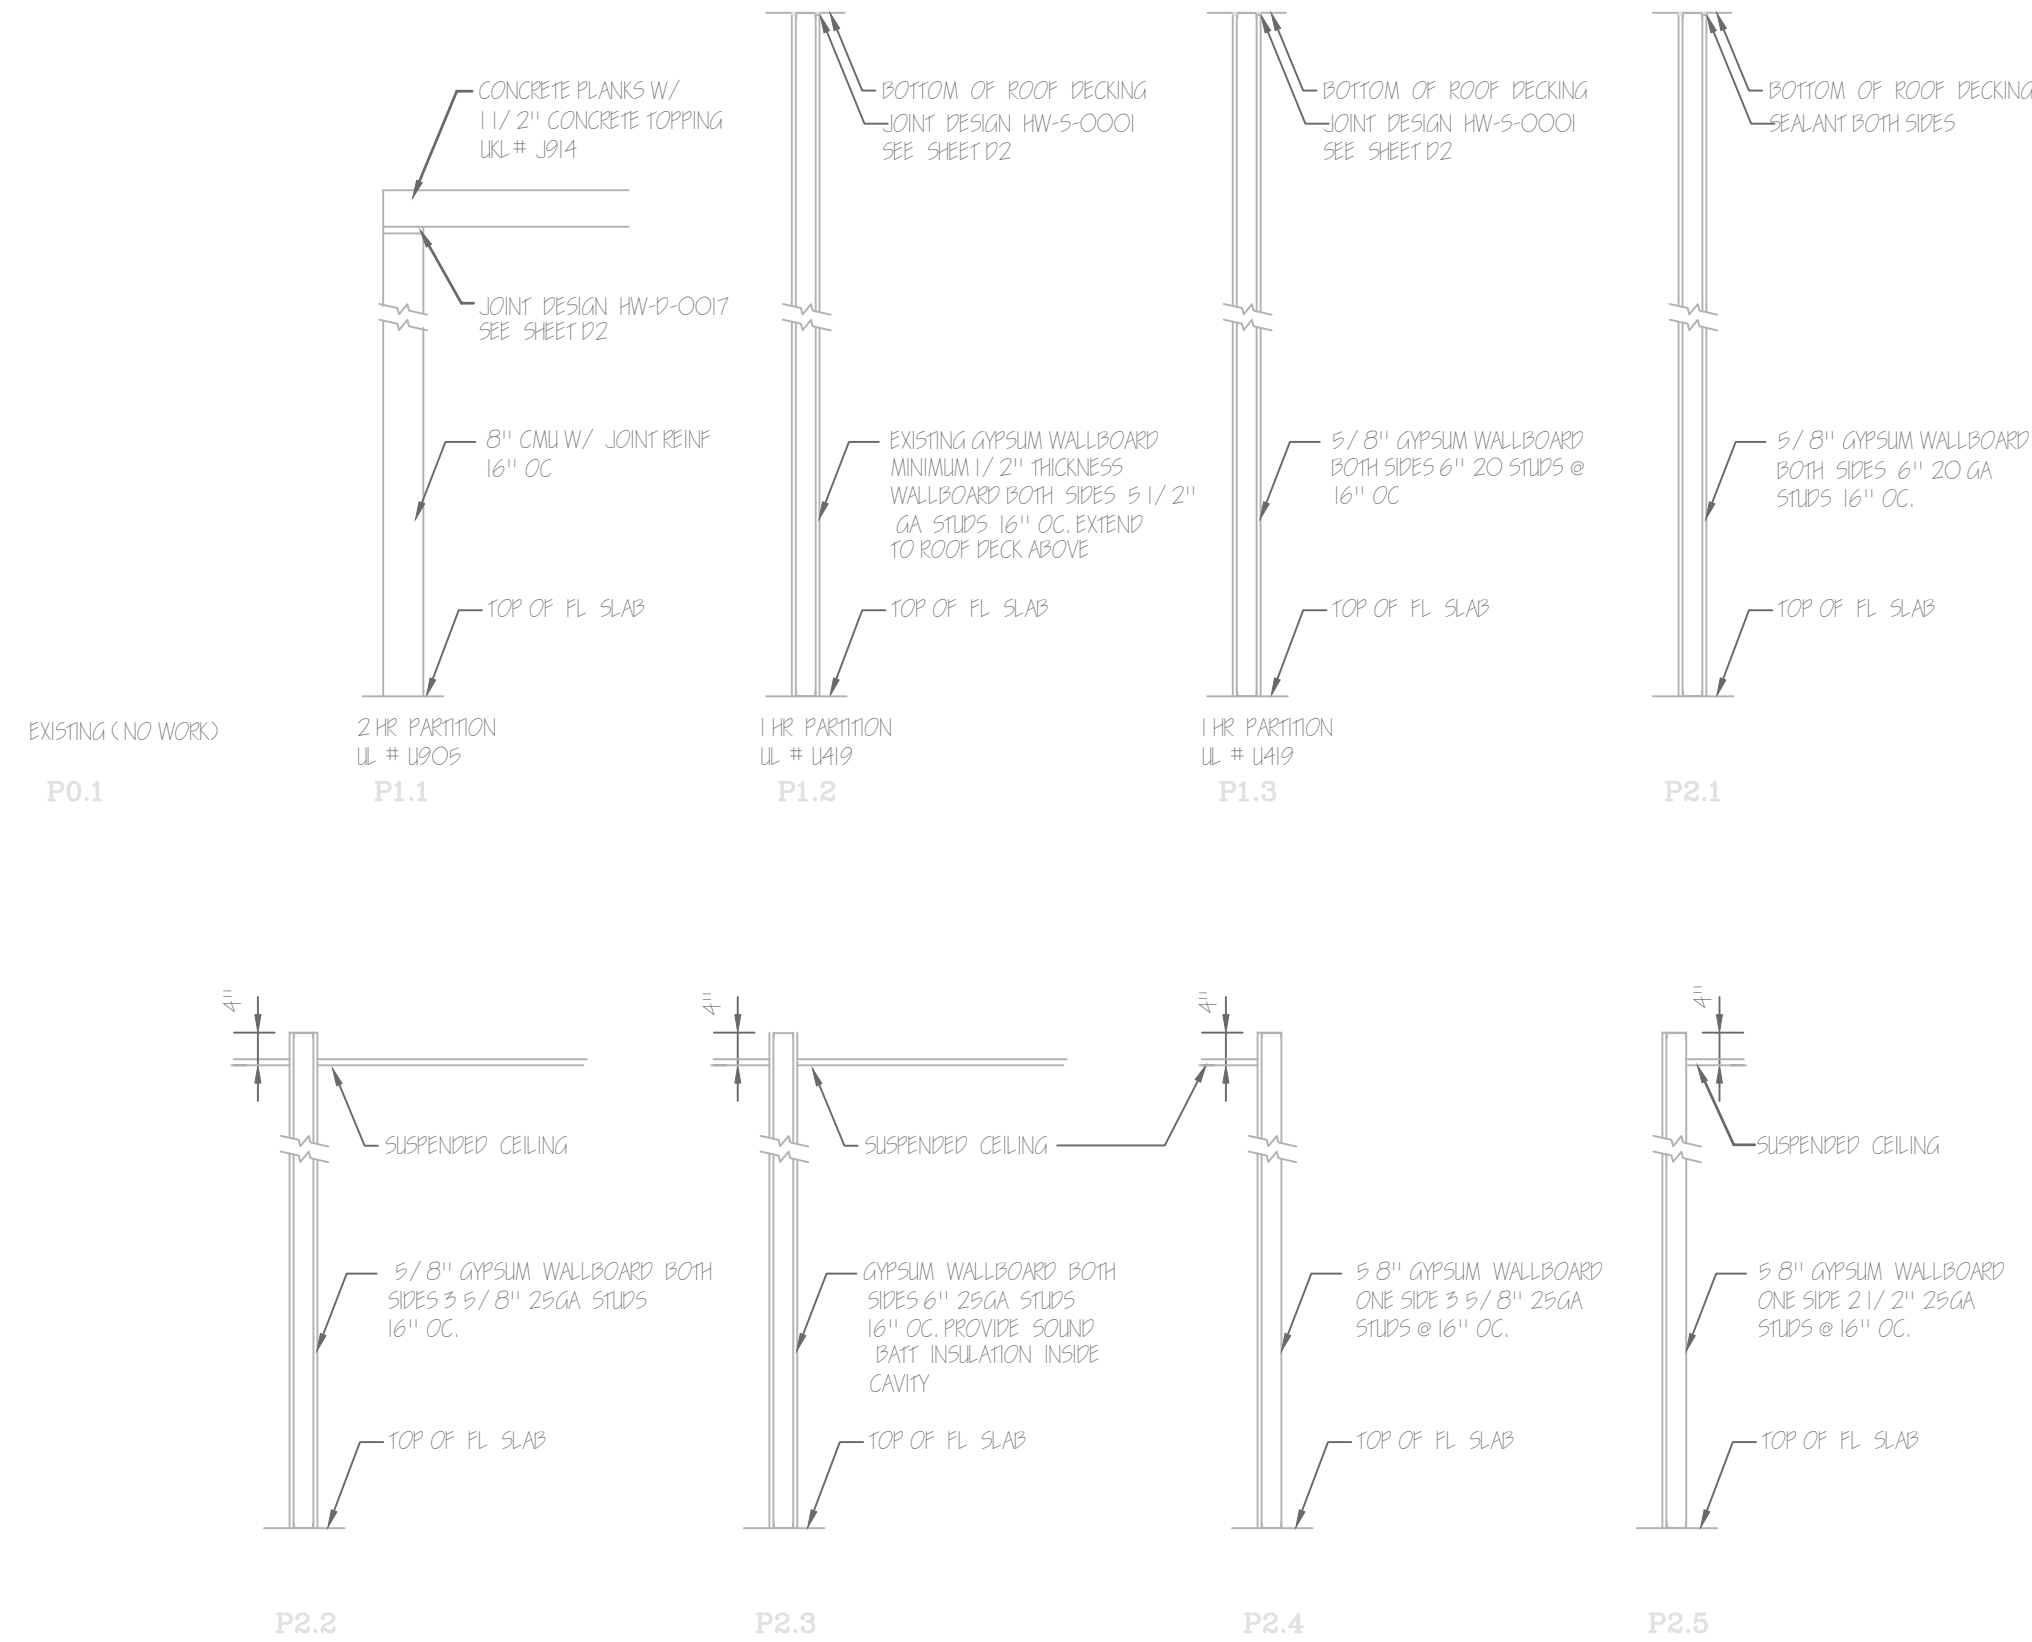

FINISH SCHEDULE

RM #	SPACE	FLOOR	BASE	WALLS	CEILING	CLG HT
101	VESTIBULE	EX (NO WORK)				
102	SALES	EX C-POL	V	EX GB-P	EX ST	----
103	STORAGE	EX C-POL	V	EX GB-P	EX ACT	----
104	WAITRESS STATION	EX C-POL	V	EX GB-P	EX ST	----
105	COOLER	EX C-EP	EP	WALLS & CEILING BY COOLER MFG		
106	DINING	EX C-POL	V	EX GB-P	EX ST	----
107	BAR	EX C-EP	EP	EX GB-P	ACT	10'-0"
108	DINING	EX C-POL	V	EX GB-P	EX ST	----
109	EXISTING OFFICE DELETED					----
110	EXISTING OFFICE DELETED					----
111	EXISTING OFFICE DELETED					----
112	BREWERY	EX C-POL	V	EX GB-P / GB-P	EX ST	----
113	GRAIN ROOM	EX C-POL	V	EX GB-P / GB-P	EX ST	----
114	BOILER	EX C-POL	----	CMU-P / EX GB-P	C ST	9'-4"
115	LAB	EX C-POL	V	EX GB-P / GB-P	EX ST	----
116	COOLER	EX C-EP	V	WALLS & CEILING BY COOLER MFG		
117	EXISTING OFFICE	EX C-POL	V	EX GB-P / GB-P	EX ACT	----
118	EXISTING OFFICE	EX C-POL	V	EX GB-P / GB-P	EX ACT	----
119	DRY STORAGE	EX C-POL	V	EX GB-P / GB-P	EX ACT	----
120	EMPLOYEE LOCKERS	EX C-POL	V	EX GB-P / GB-P	EX ACT	----
121	SPRINKLER RISER	EX C-POL	V	EX GB / GB	EX ST	----
122	EXISTING TOILET	EX C-POL	V	EX GB-P / GB-P	EX ACT	----
123	EXISTING TOILET	EX C-POL	V	EX GB-P / GB-P	EX ACT	----
124	EXISTING TOILET	EX C-POL	V	EX GB-P / GB-P	EX ACT	----
125	EXISTING TOILET	EX C-POL	V	EX GB-P / GB-P	EX ACT	----
126	CORRIDOR	EX C-POL	V	EX GB-P / GB-P	EX ACT	----
127	CORRIDOR	EX C-POL	V	EX GB-P / GB-P	EX ACT	----
128	COOLER			FLOORS, WALLS & CEILING BY COOLER MFG		
129	FREEZER			FLOORS, WALLS & CEILING BY COOLER MFG		
130	KITCHEN	EX C-EP	EP	EX GB-FRP / GB-FRP	ACT-1	9'-0"
131	DRY STORAGE	EX C-POL	V	EX GB-P	EX ACT	----
132	CORRIDOR	EX C-POL	V	EX GB-P / GB-P	EX ACT	----
133	ELECT / MECH ROOM	EX C-POL	----	EX GB-P	EX ACT	----
134	SPECIAL EVENTS	EX C-POL	V	EX GB-P / GB-P	EX ACT	----
135	SPECIAL EVENTS	EX C-POL	V	EX GB-P / GB-P	EX ACT	----
136	WOMEN	EX C-CT	CT	CT	ACT	9'-0"
137	MEN	EX C-CT	CT	CT	ACT	9'-0"
138	SPECIAL EVENTS	EX C-POL	V	EX GB-P	EX ACT	----

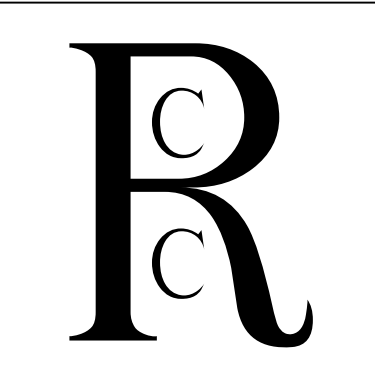

ROBERT C. CANTER, AIA
ARCHITECT
HIGH POINT, NORTH CAROLINA
PHONE: (704) 884-4543
E-MAIL: rc@rcarchitect.com

INTERIOR ALTERATIONS FOR
HIGH PINT PUBLIC HOUSE & BREWERY
NORTH CAROLINA
1114 EASTCHESTER DRIVE
HIGH POINT


ALL DRAWINGS, SPECIFICATIONS, AND OTHER DOCUMENTS PREPARED BY THE ARCHITECT FOR THIS PROJECT ARE HEREBY FOR THE ARCHITECT'S SERVICE FOR USE SOLELY WITH RESPECT TO THIS PROJECT AND, UNLESS OTHERWISE PROVIDED IN WRITING BY THE ARCHITECT, THE ARCHITECT SHALL BE DEEMED THE AUTHOR OF THESE DOCUMENTS AND SHALL REMAIN A COMMON LAW, STATUTORY AND OTHER RIGHTS, INCLUDING COPYRIGHT. THE OWNER SHALL BE PERMITTED TO REPRODUCE COPIES OF THESE DOCUMENTS INCLUDING REPRODUCIBLE COPIES FOR INFORMATION AND REFERENCE IN CONNECTION WITH THE OWNER'S USE AND OCCUPANCY OF THE PROJECT. THESE DOCUMENTS SHALL NOT BE USED BY THE OWNER OR OTHERS ON THIS PROJECT OR OTHER THAN THIS ONE UNLESS AGREED TO IN WRITING BY THE ARCHITECT.

PROJECT NO.	19-05
DRAWN BY	
DATE	6-5-19
REVISIONS	
SEAL	
SHEET	A2


A2

A1

SWINGING DOOR APPROACHES

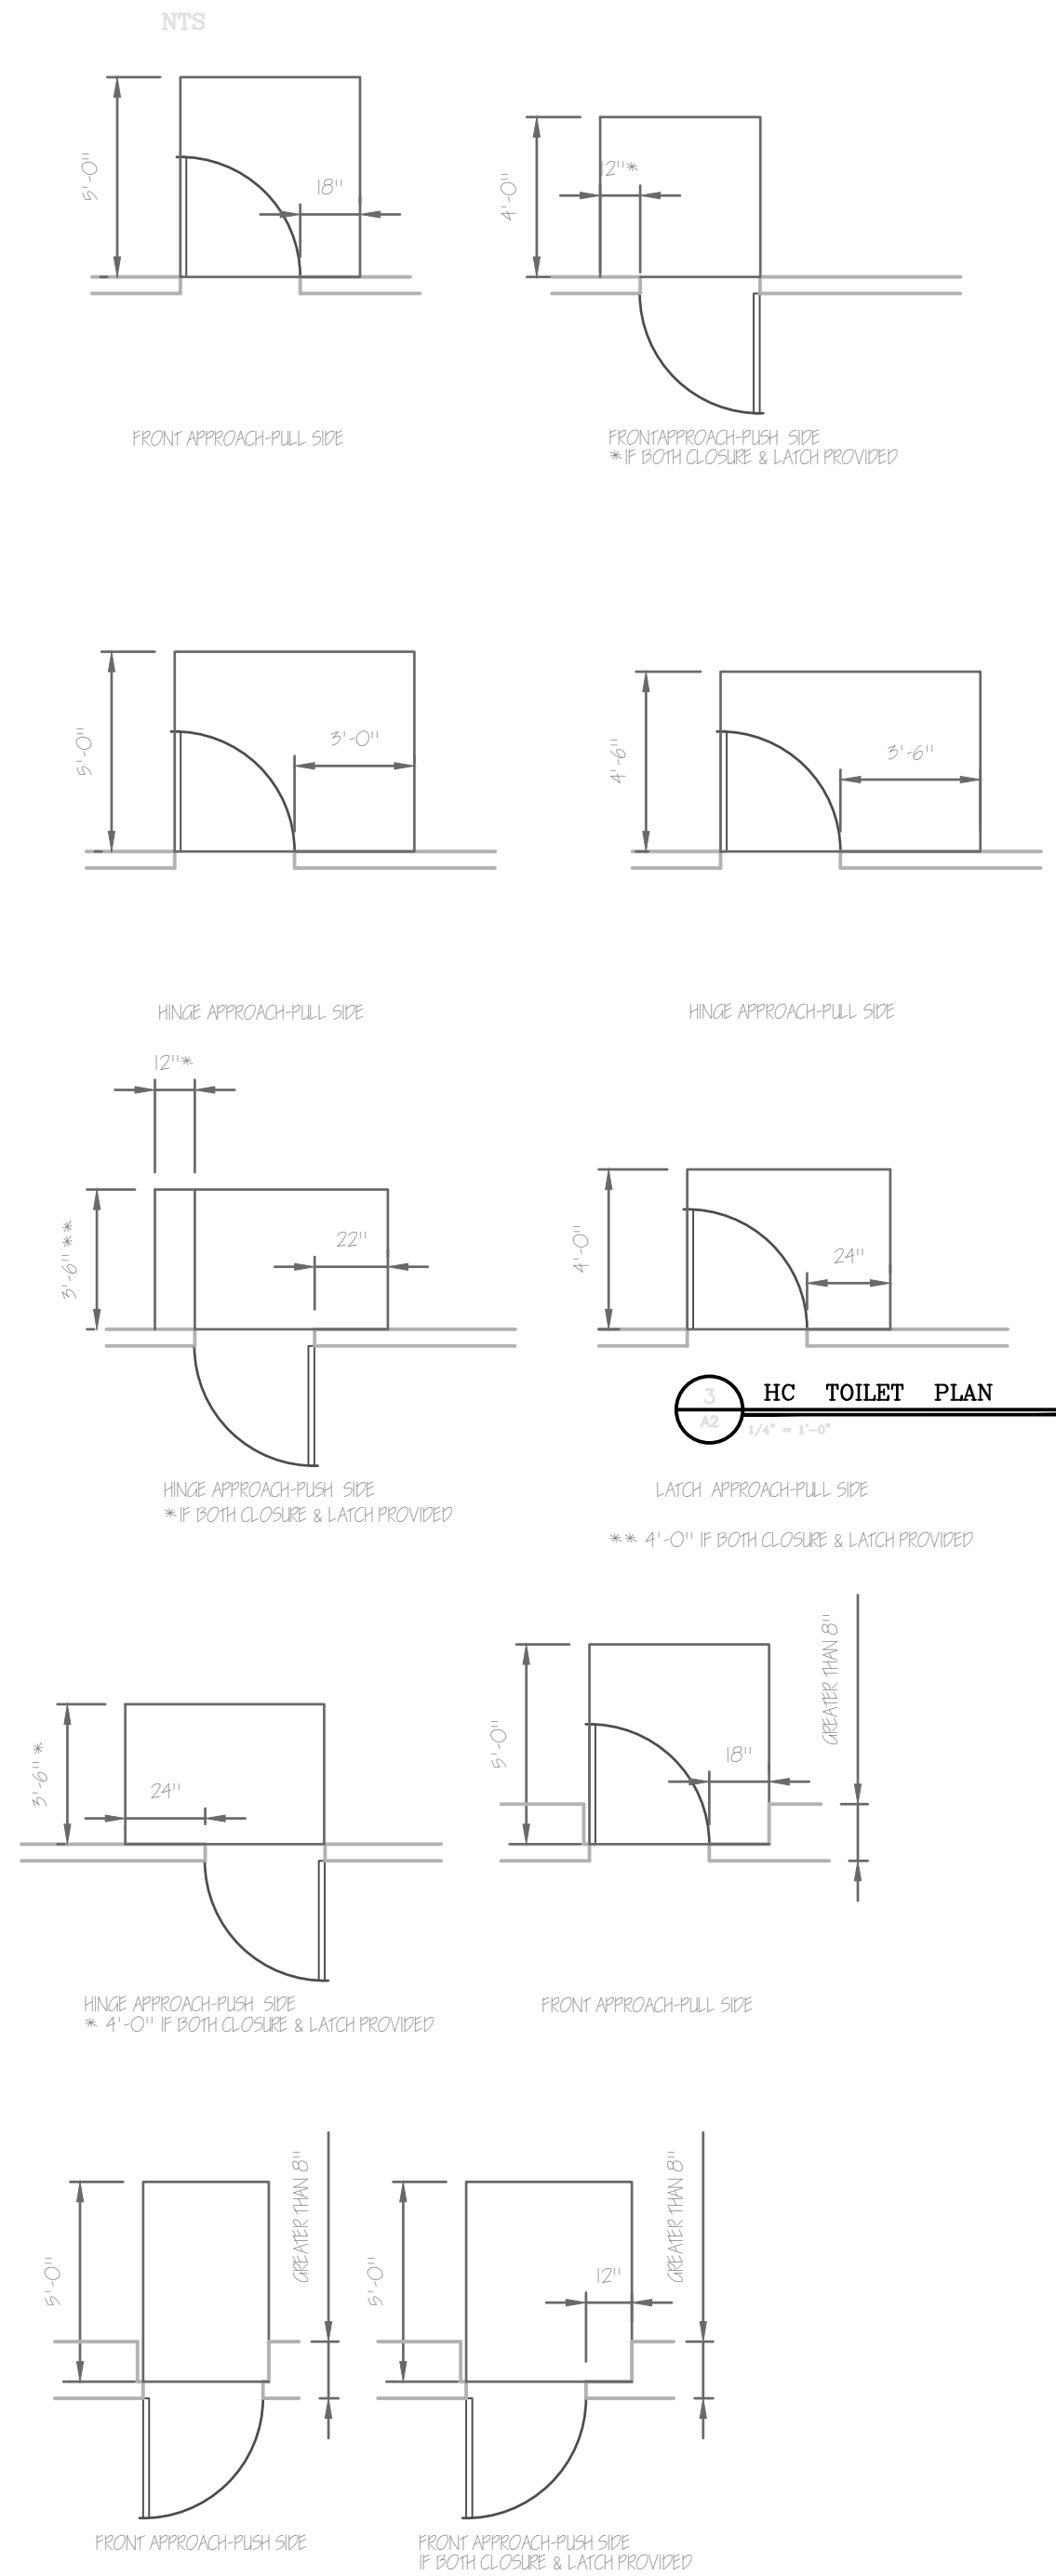


DOOR JAMBS

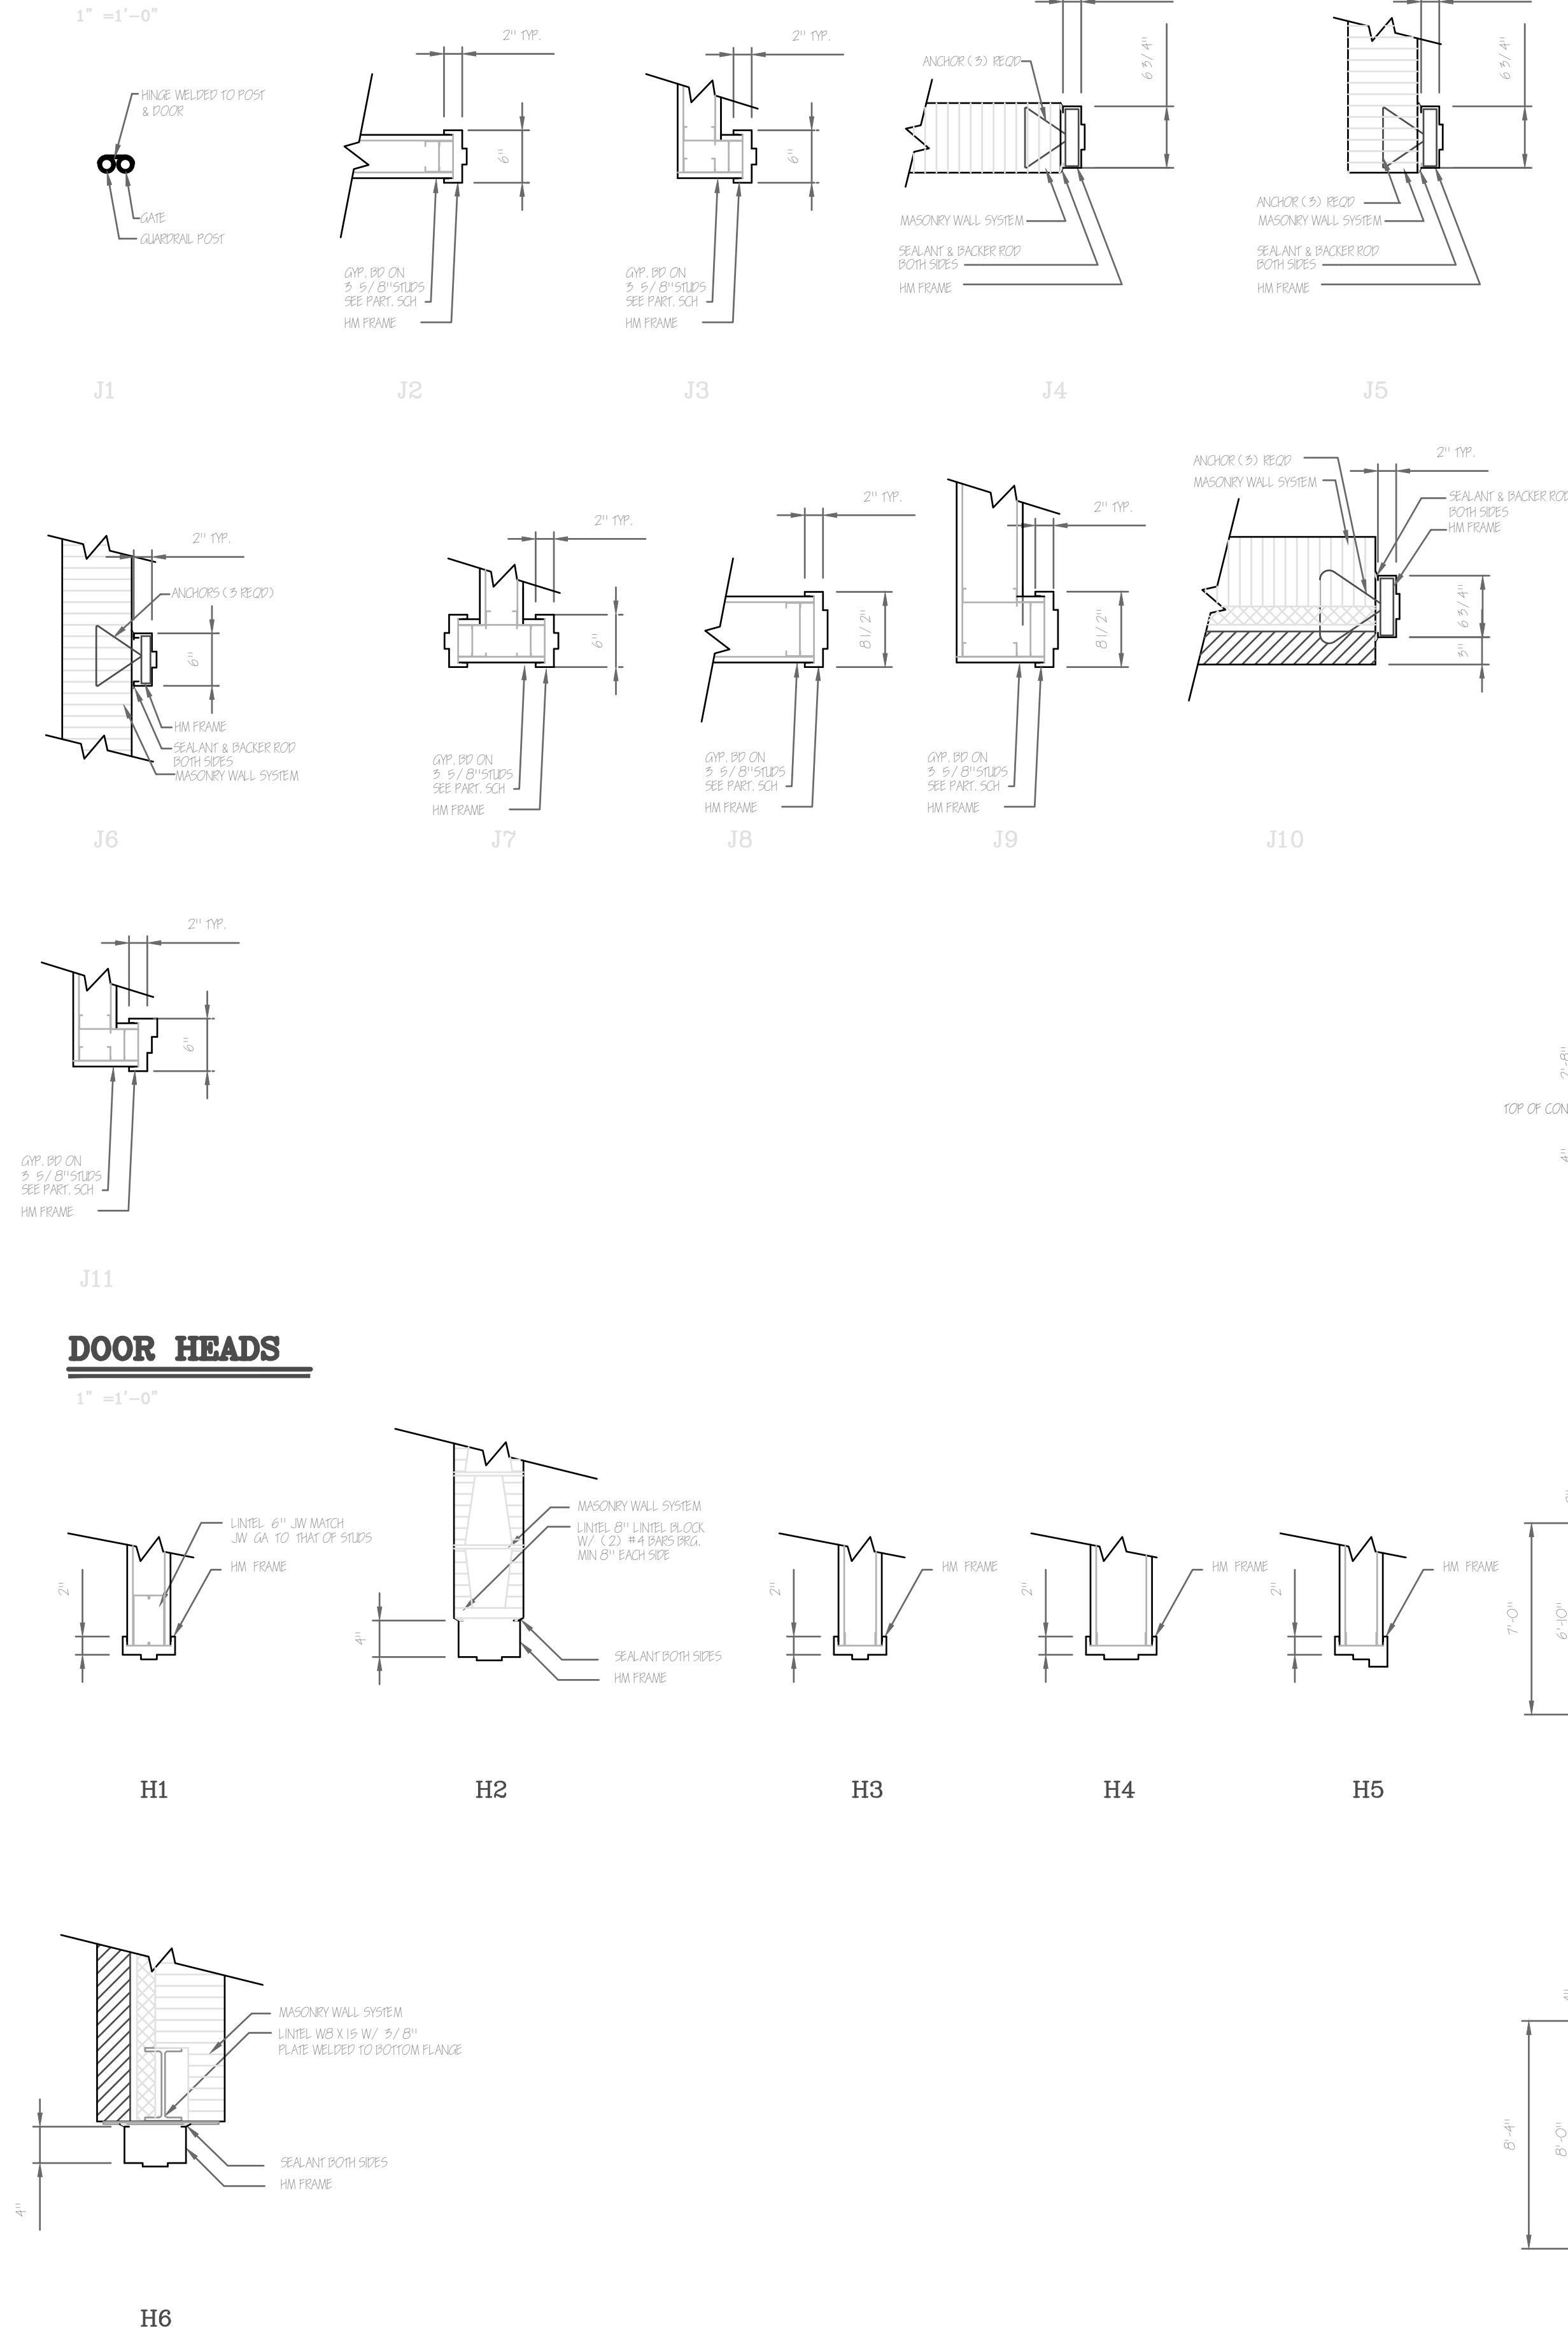


DOOR SCHEDULE

DR#	SIZE	DOOR TYPE	FRAME MAT. TYPE	JAMB MAT.	HEAD	NOTES
101	5'-0" X 7'-0"	EXISTING NO WORK				
102	5'-0" X 7'-0"	EXISTING NO WORK				
103	5'-0" X 7'-0"	EXISTING NO WORK				
104	5'-0" X 7'-0"	EXISTING NO WORK				
105	5'-0" X 7'-0"	EXISTING NO WORK				
106	5'-0" X 7'-0"	EXISTING NO WORK				
107	5'-0" X 7'-0"	EXISTING NO WORK				
108	5'-0" X 7'-0"	EXISTING NO WORK				
109	5'-0" X 7'-0"	EXISTING NO WORK				
110	5'-0" X 2'-8"	(GATE)	D1	STEEL	----	
111	5'-0" X 7'-0"	D1	STEEL	----	J1	----
112	5'-0" X 7'-0"	D2	WP	F1	HA	J2 / J3
113	5'-0" X 7'-0"	D3	HA	F5	HA	J4 / J5
114	5'-0" X 7'-0"	D4	WP	F2	HA	J2 / J6
115	5'-0" X 7'-0"	COOLER DOOR BY COOLER MFG				
116	5'-0" X 7'-0"	EXISTING NO WORK				
117	5'-0" X 7'-0"	D2	WP	F1	HA	J2 / J7
118	5'-0" X 7'-0"	D2	WP	F1	HA	J2 / J7
119	5'-0" X 7'-0"	D2	WP	F1	HA	J2 / J7
120	5'-0" X 7'-0"	DELEED				
121	5'-0" X 7'-0"	D4	WP	F2	HA	J2 / J5
122	5'-0" X 7'-0"	D2	WP	F1	HA	J2
123	5'-0" X 7'-0"	COOLER DOOR BY COOLER MFG				
124	5'-0" X 7'-0"	D4	WP	F2	HA	J5 / J9
125	5'-0" X 7'-0"	EXISTING NO WORK				
126	5'-0" X 7'-0"	EXISTING NO WORK				
127	5'-0" X 7'-0"	EXISTING NO WORK				
128	5'-0" X 7'-0"	D5	HA	F4	HA	J10
129	5'-0" X 7'-0"	D2	WP	F1	HA	J11
130	5'-0" X 7'-0"	FREEZER DOOR BY FREEZER MFG				
131	5'-0" X 7'-0"	COOLER DOOR BY COOLER MFG				
132	5'-0" X 7'-0"	DELEED				
133	5'-0" X 7'-0"	D2	WP	F1	HA	J2
134	5'-0" X 7'-0"	EXISTING NO WORK				
135	5'-0" X 7'-0"	D4	WP	F2	HA	J2 / J7
136	5'-0" X 7'-0"	D4	WP	F2	HA	J2 / J7
137	5'-0" X 7'-0"	D4	WP	F2	HA	J2
138	5'-0" X 7'-0"	D4	WP	F2	HA	J2 / J5
139	5'-0" X 7'-0"	D4	WP	F2	HA	J2 / J5
140	5'-0" X 7'-0"	DELEED				
141	5'-0" X 7'-0"	EXISTING NO WORK				
142	5'-0" X 7'-0"	EXISTING NO WORK				

DOOR TYPES

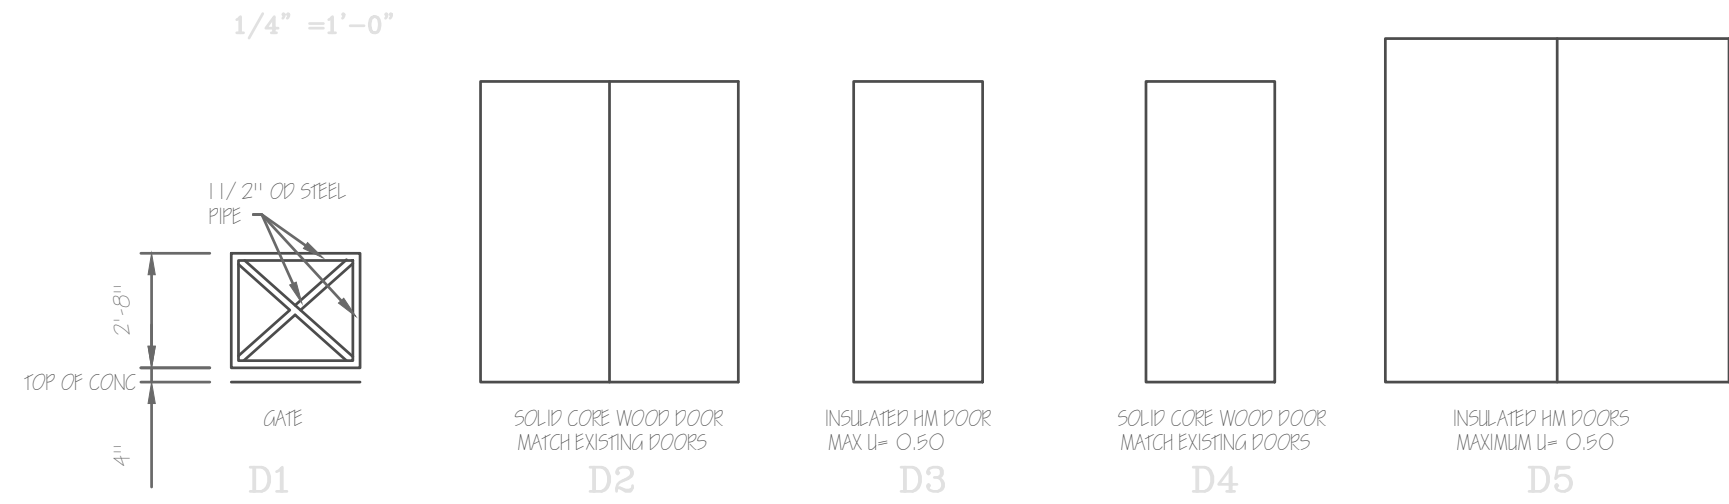

FRAME TYPES

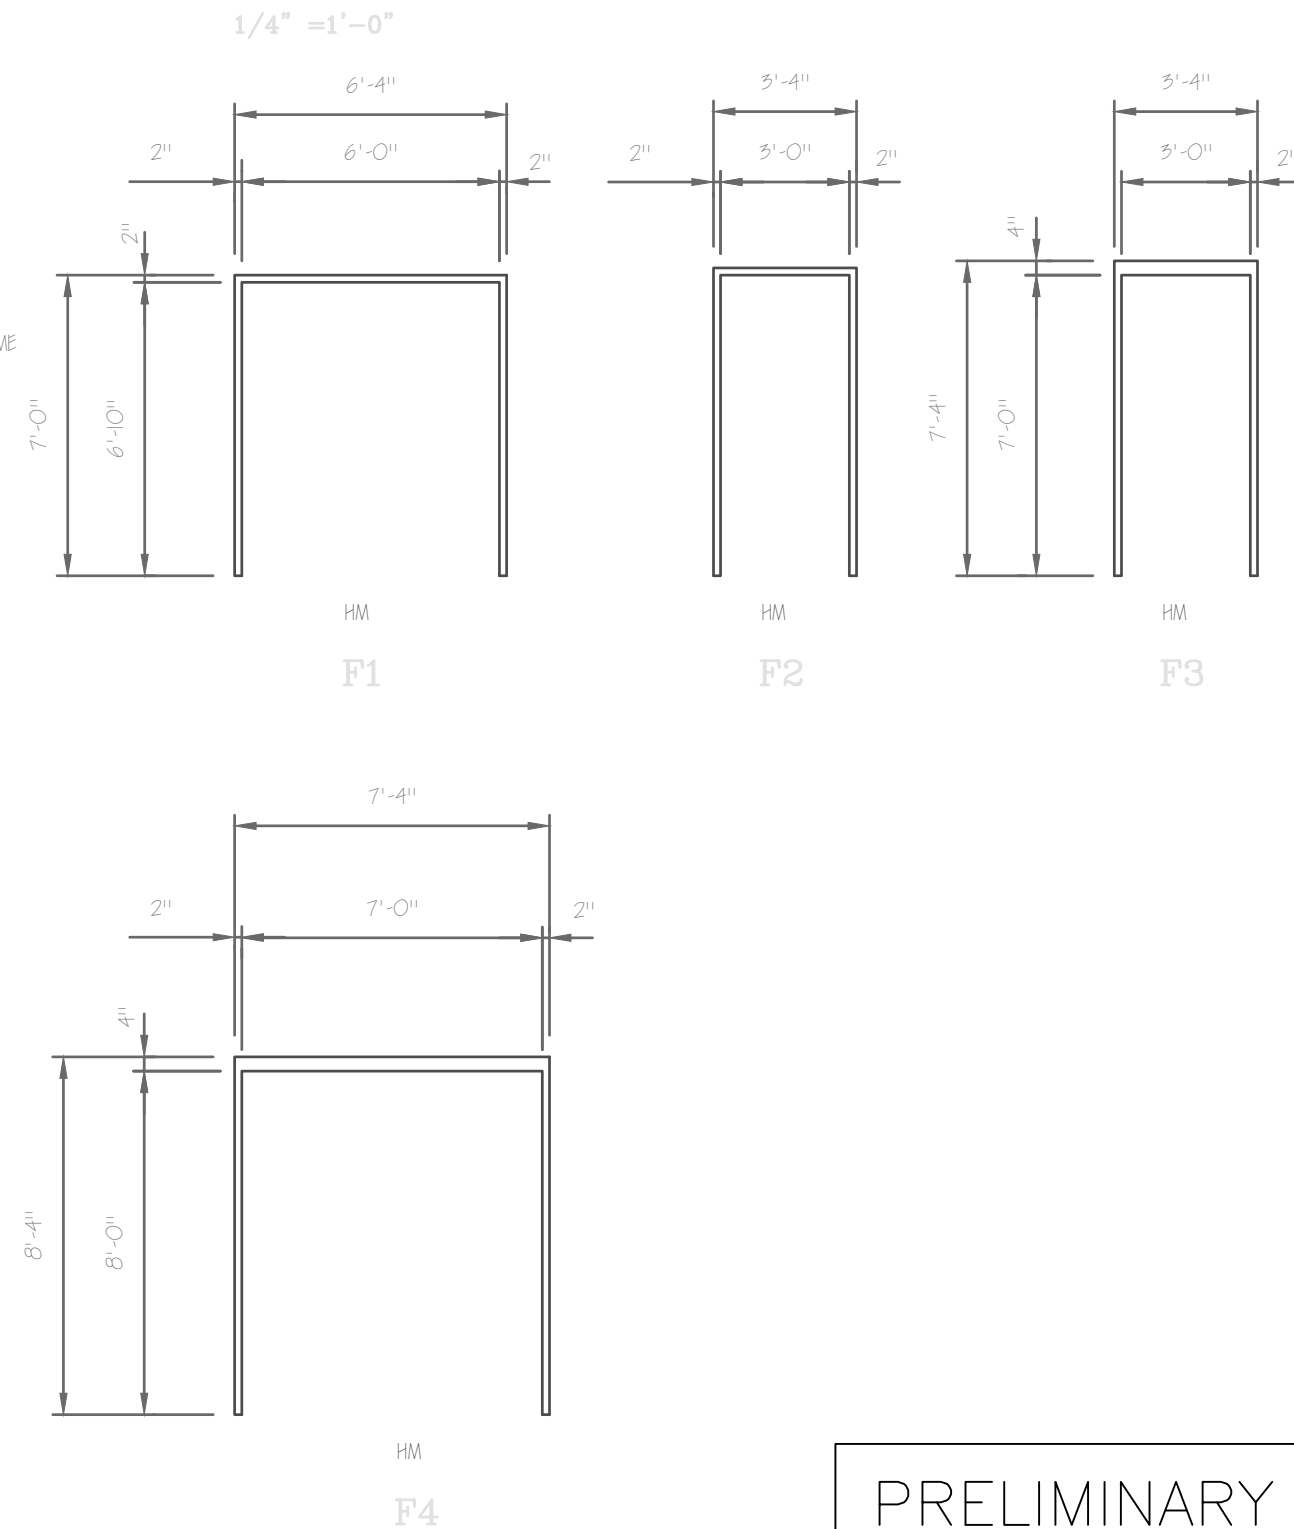


PRELIMINARY
NOT FOR CONSTRUCTION

ROBERT C. CANTER, AIA
1514 WESTCHESTER DRIVE
HIGH POINT, NORTH CAROLINA
27262
PHONE: (336) 884-4540
E-MAIL: Rcant@earthlink.net

INTERIOR ALTERATIONS FOR
HIGH PINT PUBLIC HOUSE & BREWERY
1114 EASTCHESTER DRIVE
NORTH CAROLINA
HIGH POINT


ALL DRAWINGS, SPECIFICATIONS, AND OTHER DOCUMENTS PREPARED BY THE ARCHITECT FOR THIS PROJECT ARE INSTRUMENTS OF THE ARCHITECT'S SERVICE FOR USE SOLELY WITH RESPECT TO THIS PROJECT AND, UNLESS OTHERWISE PROVIDED IN WRITING BY THE ARCHITECT, THE ARCHITECT SHALL BE DEEMED THE AUTHOR OF THESE DOCUMENTS AND SHALL RETAIN ALL COMMON LAW, STATUTORY AND OTHER RIGHTS INCLUDING COPYRIGHT. THE OWNER SHALL BE PERMITTED TO RETAIN COPIES OF THESE DOCUMENTS INCLUDING REPRODUCTION COPIES FOR INFORMATIONAL PURPOSES IN CONNECTION WITH THE OWNER'S USE AND OCCUPANCY OF THE PROJECT. THESE DOCUMENTS SHALL NOT BE USED BY THE OWNER OR OTHERS ON PROJECTS OTHER THAN THIS ONE UNLESS AGREED TO IN WRITING BY THE ARCHITECT.

19-05
6-5-18
9-20-19
5109
ROBERT C. CANTER
REGISTERED ARCHITECT
NORTH CAROLINA
HIGH POINT, NC
A3
9

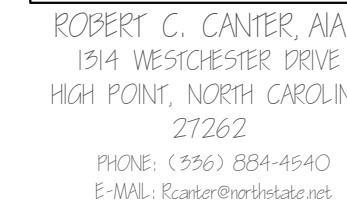

NORTH CAROLINA

OF 5

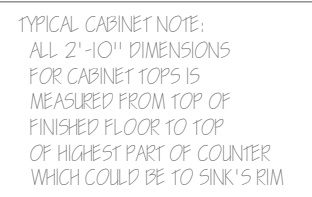

EXISTING WINDOW
(NO WORK)



$$\frac{A}{M}$$
$$1/4'' = 1'-0''$$


ALL DRAWINGS, SPECIFICATIONS, AND OTHER DOCUMENTS PREPARED BY THE ARCHITECT FOR THIS PROJECT ARE INSTRUMENTS OF THE ARCHITECT'S SERVICE FOR USE SOLELY WITH RESPECT TO THIS PROJECT AND, UNLESS OTHERWISE PROVIDED IN WRITING BY THE ARCHITECT, THE ARCHITECT SHALL BE DEEMED THE AUTHOR OF THESE DOCUMENTS AND SHALL RETAIN ALL COMMON LAW, STATUTORY AND OTHER RIGHTS, INCLUDING COPYRIGHT. THE OWNER SHALL BE PERMITTED TO RETAIN COPIES OF THESE DOCUMENTS INCLUDING REPRODUCIBLE COPIES FOR INFORMATION AND REFERENCE IN CONNECTION WITH THE OWNER'S USE AND OCCUPANCY OF THE PROJECT. THESE DOCUMENTS SHALL NOT BE LOANED BY THE OWNER OR OTHERS ON PROJECTS OTHER THAN THIS ONE UNLESS AGREED TO IN WRITING BY THE ARCHITECT.



NOT FOR CONSTRUCTION


$$3/4'' = 1'-0''$$
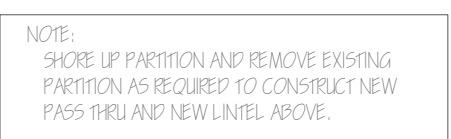
$$3/4'' = 1'-0''$$

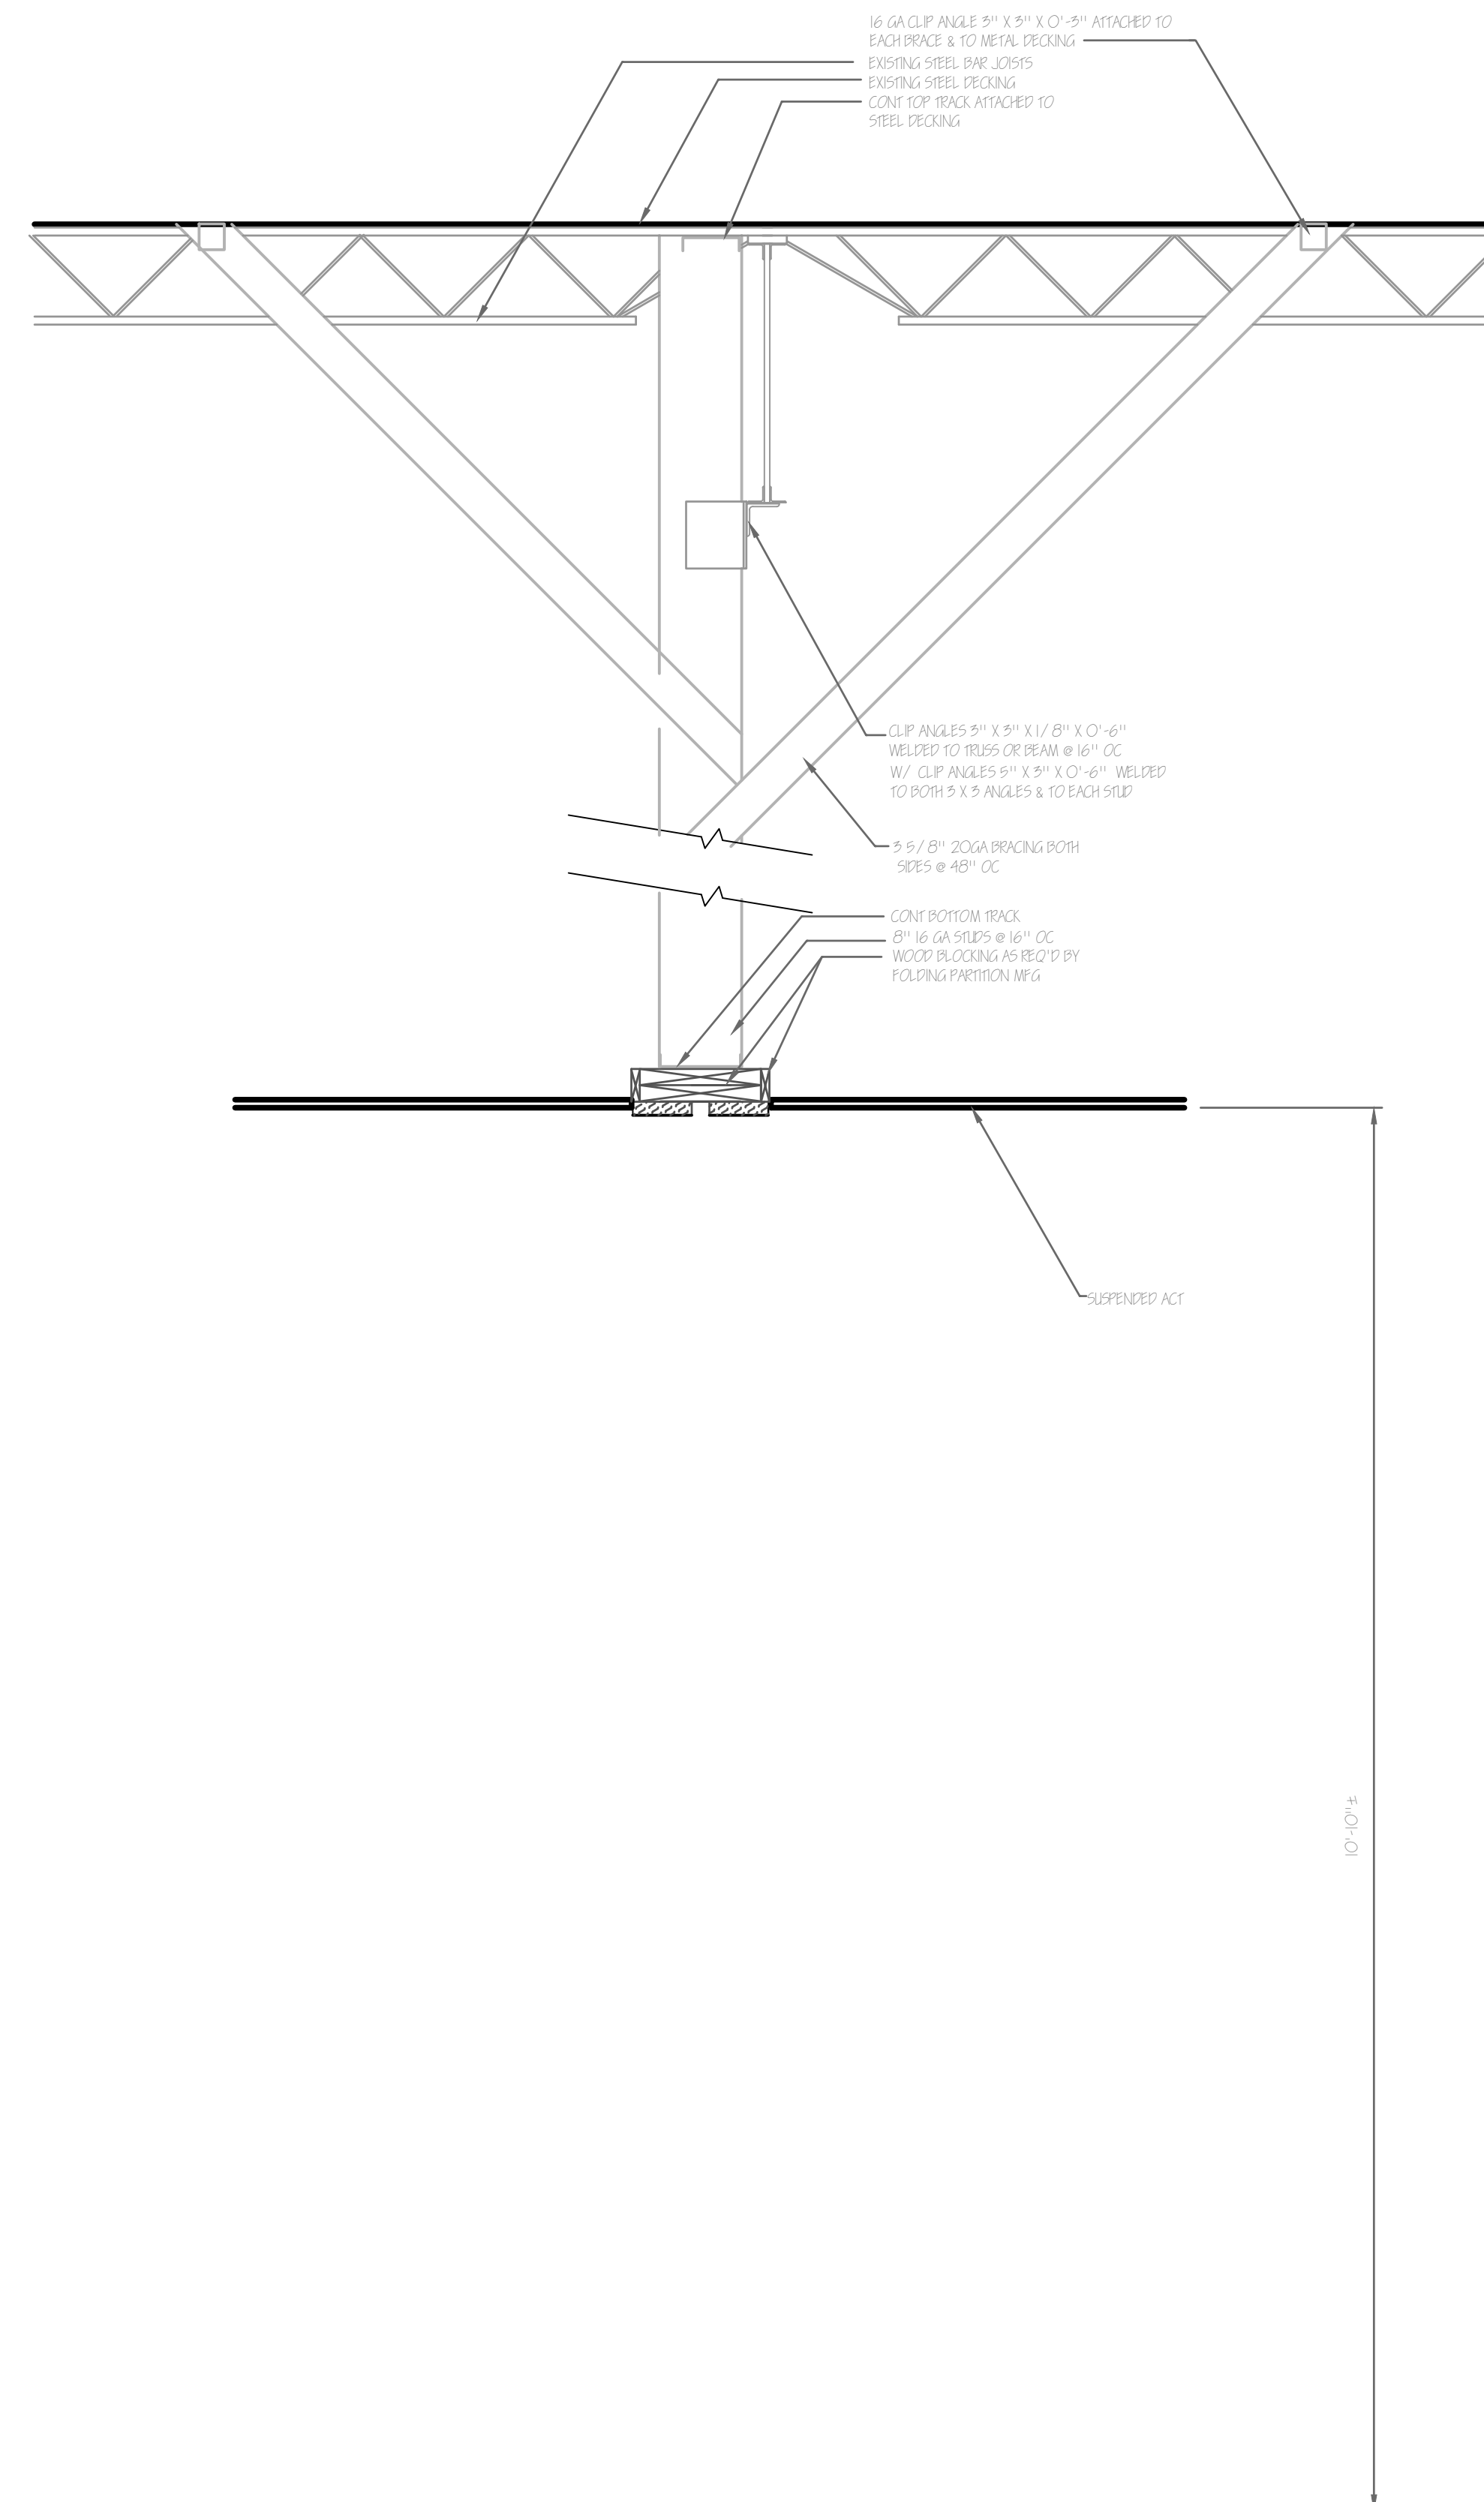


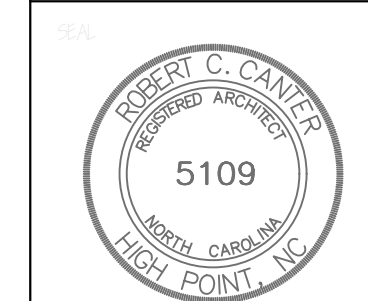
SECTION THRU SUPPORT FOR
FUTURE FOLDING PARTITION

1/3" = 1' 0"

NOT FOR CONSTRUCTION

ALL DRAWINGS, SPECIFICATIONS, AND OTHER DOCUMENTS PREPARED BY THE ARCHITECT FOR THIS PROJECT ARE INSTRUMENTS OF THE ARCHITECT'S SERVICE FOR USE SOLELY WITH RESPECT TO THIS PROJECT AND, UNLESS OTHERWISE PROVIDED IN WRITING BY THE ARCHITECT, THE ARCHITECT SHALL BE DEEMED THE AUTHOR OF THESE DOCUMENTS AND SHALL BE RESPONSIBLE FOR LEGAL, STATUTORY AND OTHER RIGHTS, INCLUDING COPYRIGHT. THE OWNER SHALL BE PERMITTED TO RETAIN COPIES OF THESE DOCUMENTS INCLUDING REPRODUCIBLE COPIES FOR INFORMATION AND REFERENCE IN CONNECTION WITH THE OWNER'S USE AND OCCUPANCY OF THE PROJECT. THESE DOCUMENTS SHALL NOT BE LOANED, REPRODUCED BY THE OWNER OR OTHERS ON PROJECTS OTHER THAN THIS ONE UNLESS AGREED TO IN WRITING BY THE ARCHITECT.


PROJECT NO. 19-05
DRAWN BY
DATE 6-5-19
REVISIONS 9-20-19



SHEET

A5

OF 5

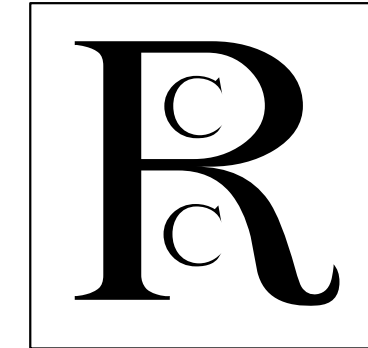

ROBERT C. CANTER, AIA
1314 WESTCHESTER DRIVE
HIGH POINT, NORTH CAROLINA
27262
PHONE: (336) 884-4540
E-MAIL: Rcanten@northstate.net

INTERIOR ALTERATIONS FOR HIGH PINT PUBLIC HOUSE & BREWERY

HIGH POINT
1114 EASCHESIER DRIVE
NORTH CAROLINA